



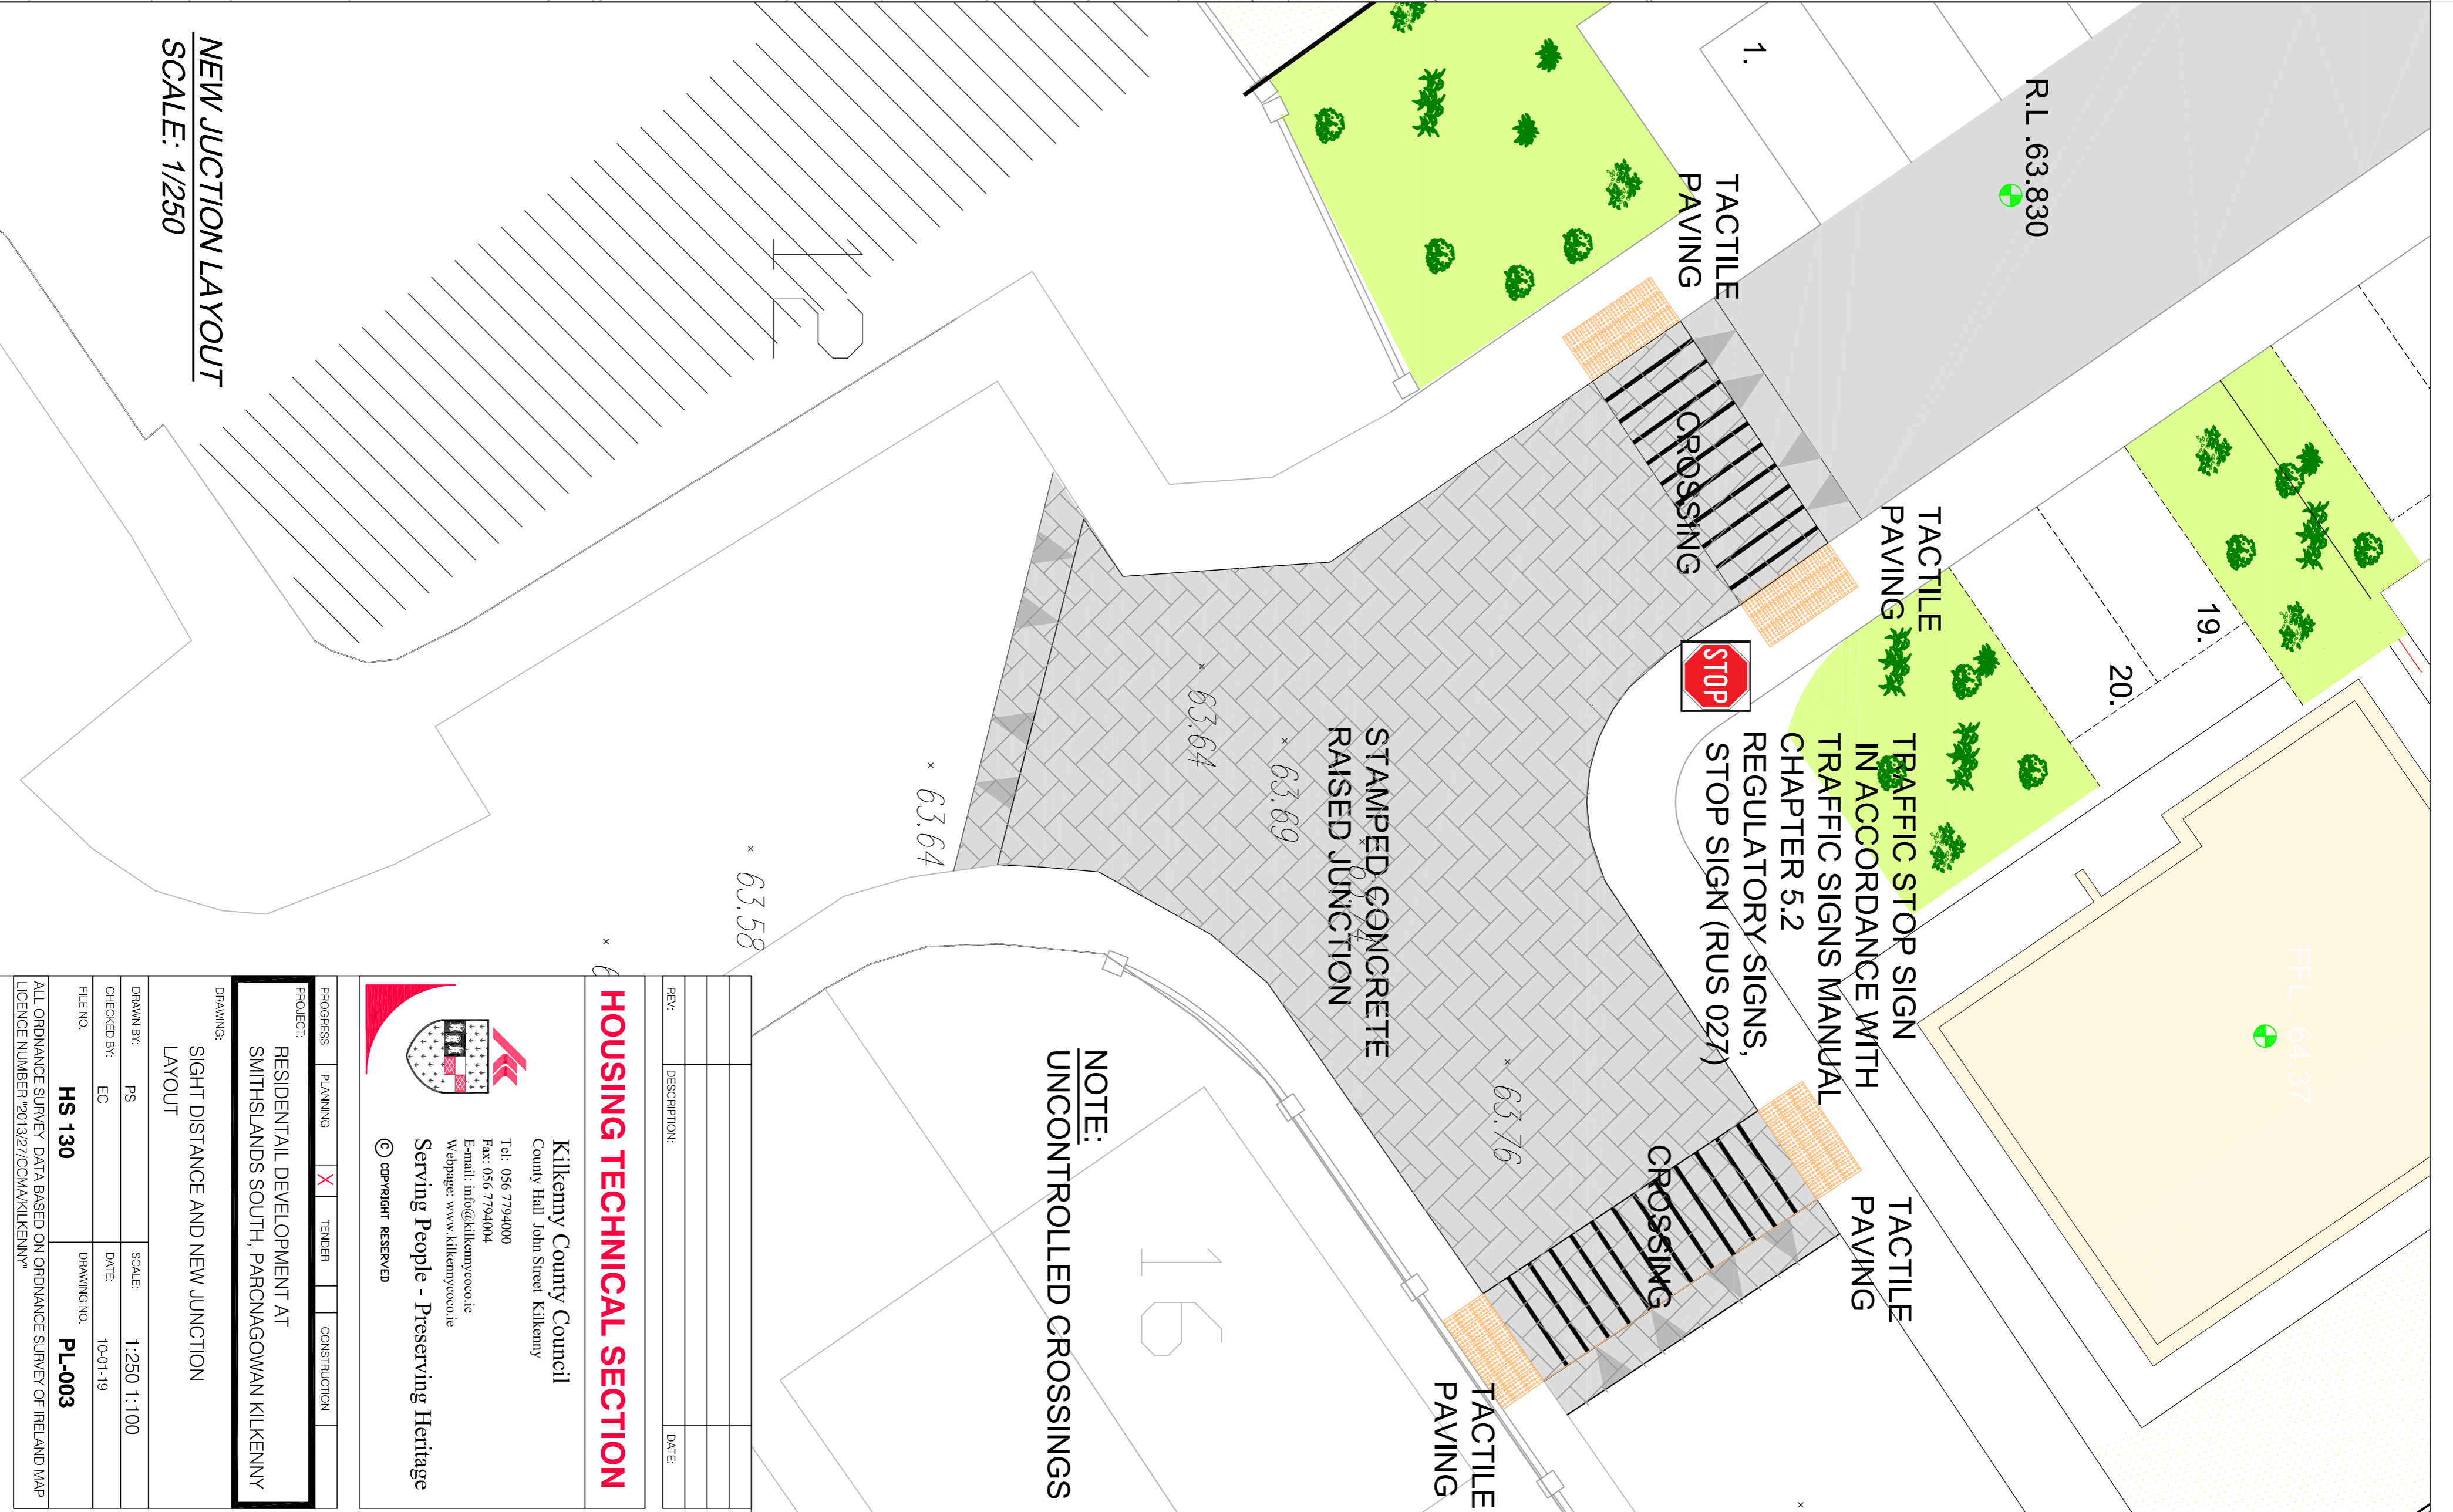

SIGHT DISTANCE AND PUBLIC LIGHTING LAYOUT
SCALE: 1/250

Comharle Chonrae Chill Chainnigh
Halls and Chonrae Stand East, Chill Chainnigh

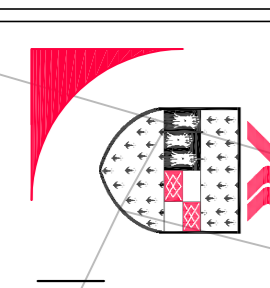

NEW JUNCTION LAYOUT
SCALE: 1/250

NOTE:
UNCONTROLLED CROSSINGS

NO.	DESCRIPTION	DATE

HOUSING TECHNICAL SECTION

Kilkenny County Council
County Hall, John Street, Kilkenny

Tel: 056 7794800 Fax: 056 7794801
Email: enquiries@kcc.ie
Website: www.kilkenny.gov.ie

Serving People - Preserving Heritage

© COPYRIGHT RESERVED

PROJECT:	RESIDENTIAL DEVELOPMENT AT SMITHSLANDS SOUTH, PARNOAGOWAN KILKENNY
PROGRESS:	PLANNING <input checked="" type="checkbox"/> TENDER <input type="checkbox"/> CONSTRUCTION <input type="checkbox"/>
DRAWING:	SIGHT DISTANCE AND NEW JUNCTION LAYOUT
DRAWN BY:	PS
CHECKED BY:	EC
SCALE:	1:250 1:100
DATE:	10/01/19
FILE NO.:	HS 130
DRAWING NO.:	PL-003
ALL ORDINANCE SURVEY DATA BASED ON ORDINANCE SURVEY OF IRELAND MAP LICENCE NUMBER 2013/27/CMA/VIK/ENNY	