


PROPOSED DRAINAGE LAYOUT FOR CAR PARK AT NEW ROSS BOAT YARD

SCALE 1:200

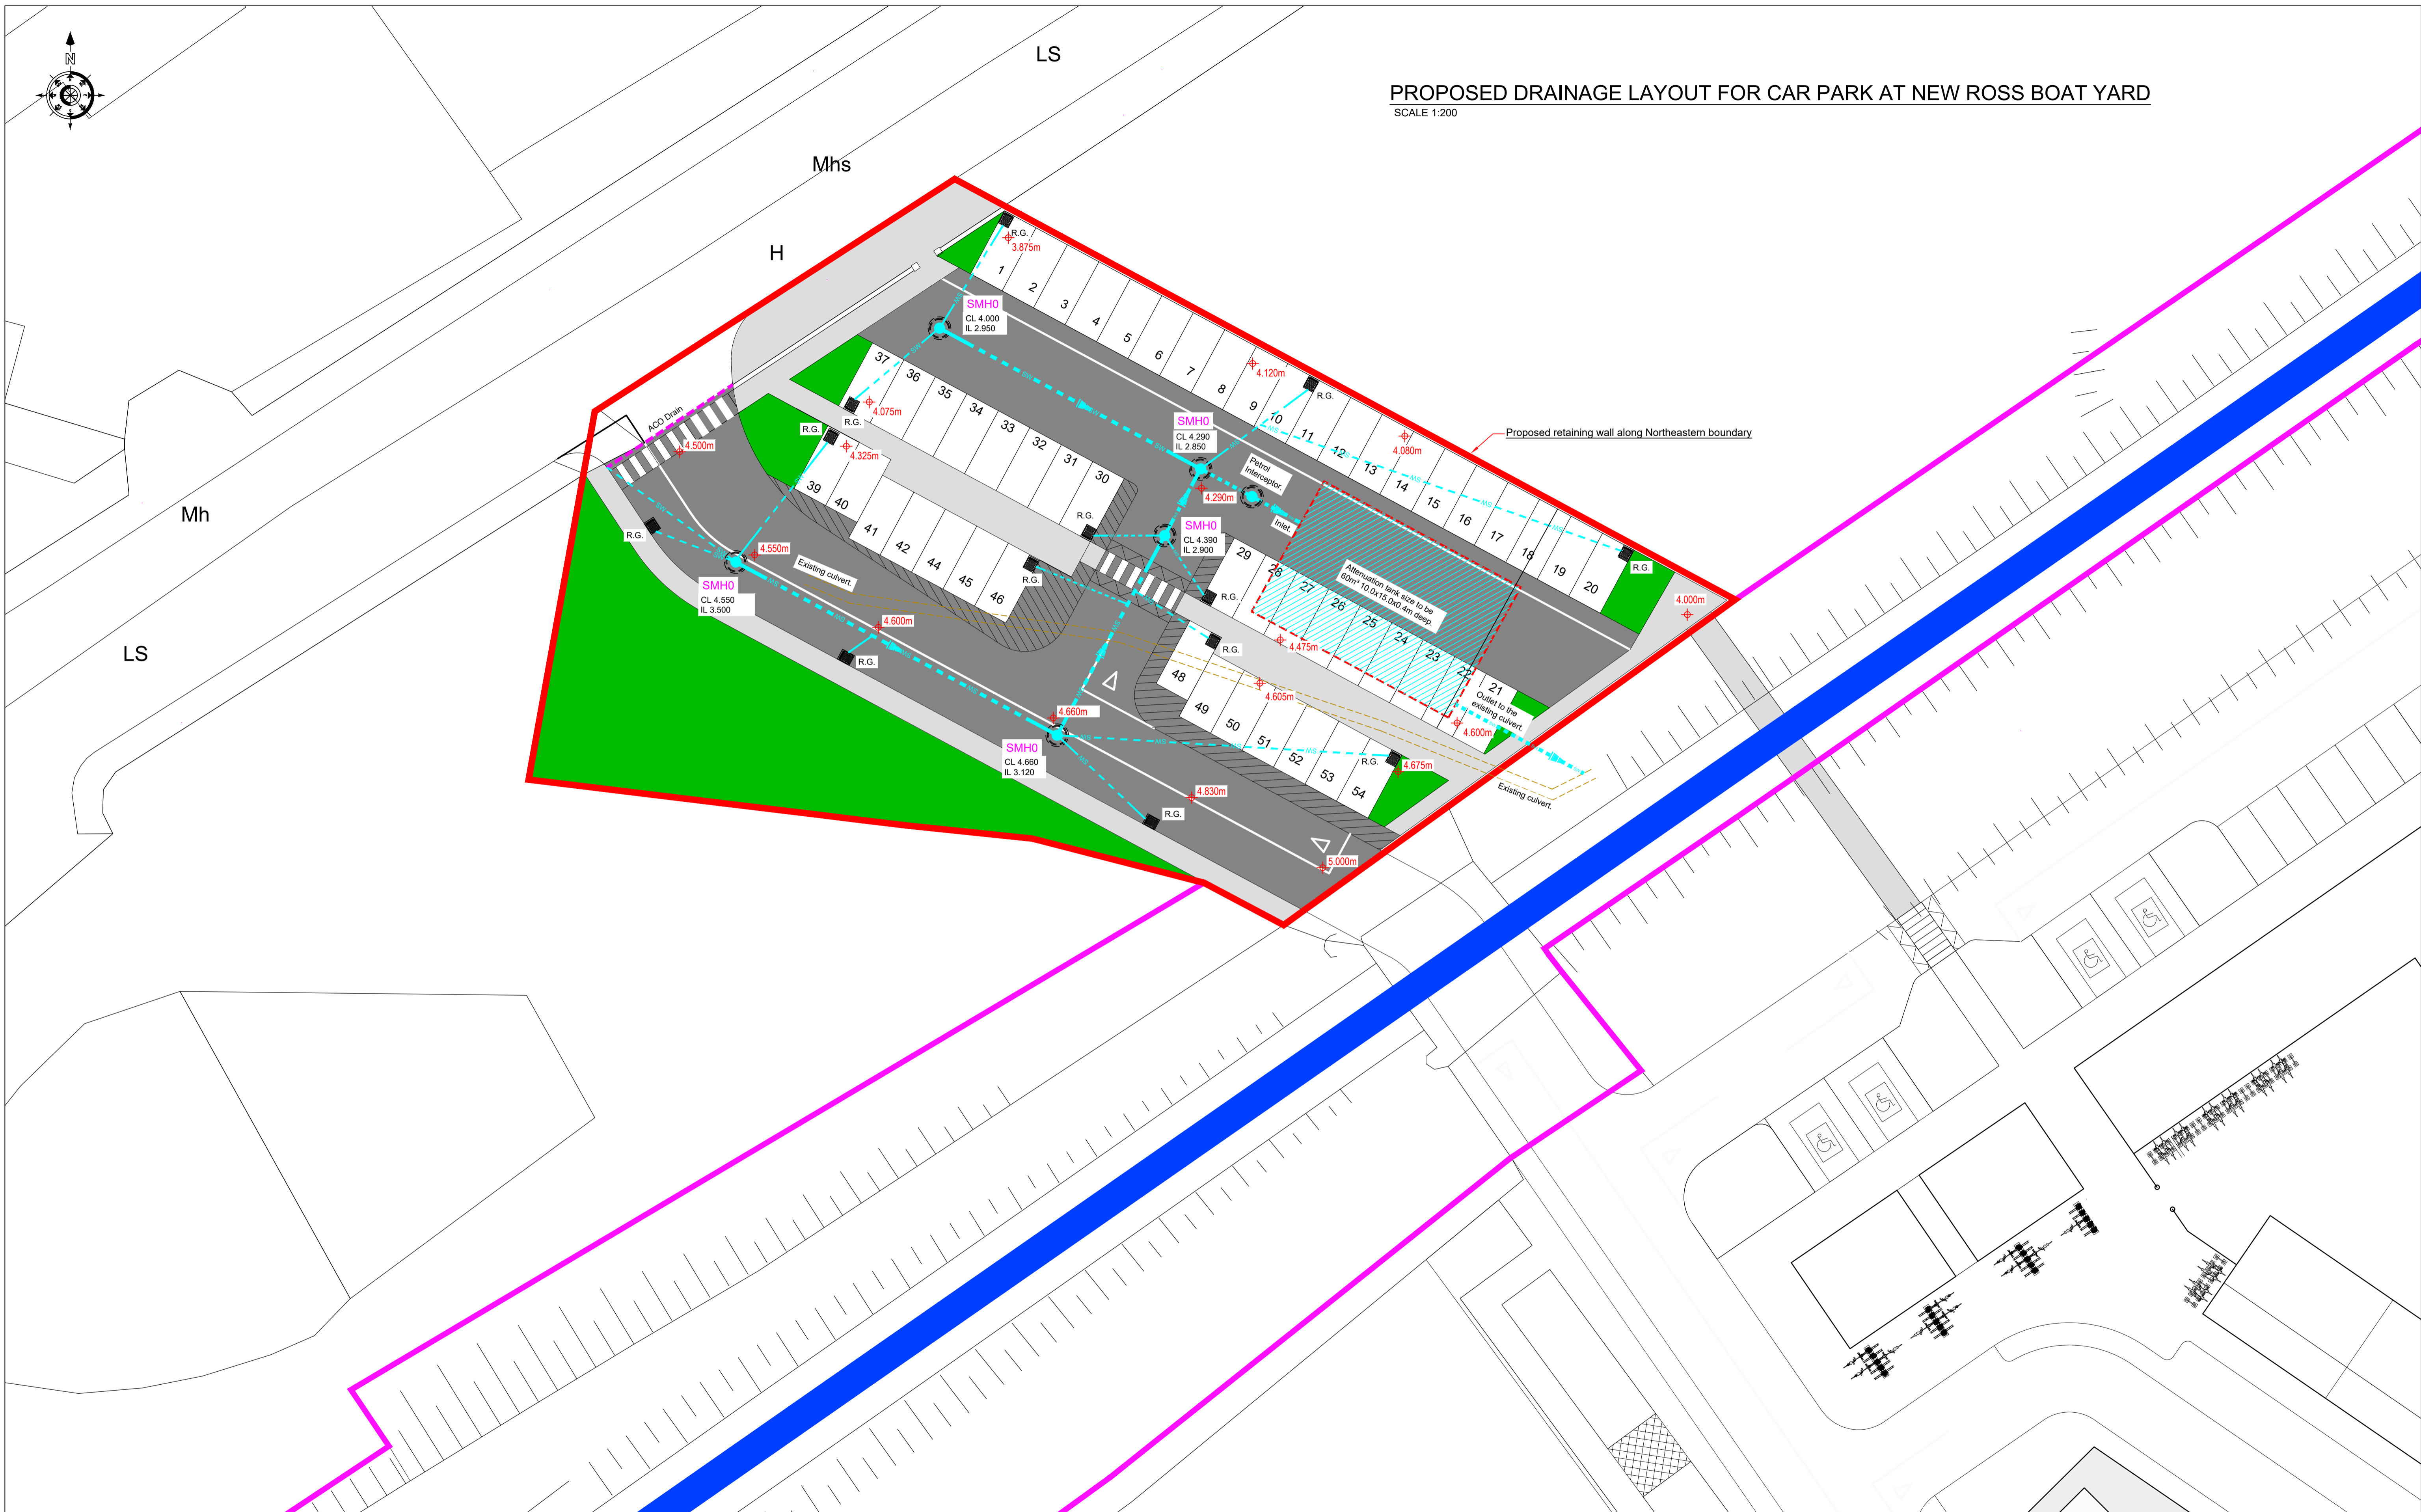

NOTES:

- DO NOT SCALE FROM THIS DRAWING. USE FIGURED DIMENSIONS IN ALL CASES.
- VERIFY DIMENSIONS ON SITE AND REPORT ANY DISCREPANCIES TO THE DESIGNERS IMMEDIATELY.
- THIS DRAWING TO BE READ IN CONJUNCTION WITH THE DESIGNERS SPECIFICATION.
- THIS DRAWING IS COPYRIGHT AND MAY ONLY BE REPRODUCED WITH THE DESIGNERS PERMISSION.
- ALL LEVELS ARE IN METERS RELATED ORDNANCE DATUM MALIN.
- ALL DIMENSIONS ARE IN METERS, UNLESS OTHERWISE STATED.
- REPRODUCED FROM THE ORDNANCE SURVEY BY PERMISSION OF THE GOVERNMENT. LICENCE No. EN 0015717.

LEGEND:

- Denotes Existing Railway Line and Proposed Greenway Route
- Denotes Proposed Greenway Boundary
- Denotes Proposed Car park Boundary



PROJECT: SOUTH EAST GREENWAY

TITLE: PROPOSED DRAINAGE FOR CAR PARK AT NEW ROSS BOAT YARD

Malachy Walsh and Partners
 Engineering and Environmental Consultants
 Cork | Tralee | London | Limerick

Park House
 Mahon Technology Park
 Bessboro Road
 Blackrock
 Cork
 T12 X251

Tel: +353 (0)21 4536400
 E-mail: cork@mwp.ie

REV	DATE	DESCRIPTION	BY	APP
P03	23.07.20	ISSUED FOR INFORMATION	BK	JOL
P02	28.04.20	ISSUED FOR INFORMATION	JL	JOL
P01	01.03.20	ISSUED FOR INFORMATION	BK	JOL
DATE	MAR 2020	SCALE @ A1	1:200	
PROJECT NUMBER	19983	DRAWING STATUS	S2	
DRAWING NUMBER	WCC01-MWP-ZZ-01-DR-C-1533	REV	P03	