


COPYRIGHT AND OWNERSHIP OF THIS DRAWING IS VESTED IN DENNANY REIDY ASSOCIATES LTD. NO PART OF THIS DOCUMENT MAY BE REPRODUCED OR TRANSMITTED IN ANY FORM OR STORED IN ANY RETRIEVAL SYSTEM OF ANY NATURE WITHOUT THE WRITTEN PERMISSION OF DENNANY REIDY ASSOCIATES AS COPYRIGHT HOLDER EXCEPT AS AGREED FOR USE ON THE PROJECT FOR WHICH THE DOCUMENT WAS ORIGINALLY ISSUED. ©
 ALL RIGHTS RESERVED BY THE LAW OF COPYRIGHT AND BY INTERNATIONAL COPYRIGHT CONVENTIONS ARE RESERVED TO DENNANY REIDY ASSOCIATES LTD. ©

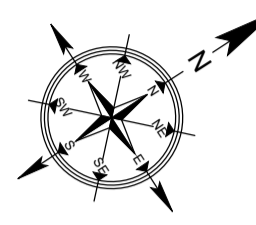

- NOTES:**
1. ALL DIMENSIONS ARE IN MILLIMETRES AND LEVELS IN METRES UNLESS NOTED OTHERWISE.
 2. USE FIGURED DIMENSIONS ONLY. DO NOT SCALE.
 3. DRAWINGS TO BE READ IN CONJUNCTION WITH ALL RELEVANT ENGINEERS, ARCHITECTS AND SERVICE ENGINEER'S DRAWINGS AND SPECIFICATIONS.
 4. ALL WORKS TO BE CARRIED OUT IN ACCORDANCE WITH CURRENT BUILDING REGULATIONS.

- LEGEND:**
- APPLICATION OUTLINE
 - - - EXISTING FOUL SEWER
 - EXISTING FOUL MANHOLE
 - - - EXISTING WATERMAIN
 - EXISTING WATERMAIN MANHOLE
 - - - EXISTING SURFACE WATER
 - EXISTING SURFACE WATER MANHOLE
 - - - EXISTING COMBINED SEWER
 - EXISTING COMBINED MANHOLE
 - EXISTING FIRE HYDRANT
 - EXISTING BOUNDARY BOX
 - EXISTING ROAD GULLY
 - EX FOUL MH = FOUL WATER MANHOLE
 - CL = COVER LEVEL
 - IL = INVERT LEVEL
 - EX COMB. MH = COMBINED MANHOLE
 - CL = COVER LEVEL
 - IL = INVERT LEVEL
 - EX SW MH = SURFACE WATER MANHOLE
 - CL = COVER LEVEL
 - IL = INVERT LEVEL
 - - - PROPOSED FOUL SEWER
 - PROPOSED FOUL MANHOLE
 - - - PROPOSED WATERMAIN
 - PROPOSED WATERMAIN MANHOLE
 - - - PROPOSED SURFACE WATER
 - PROPOSED SURFACE WATER MANHOLE
 - ic PROPOSED IRISH WATER INSPECTION CHAMBER
 - AJ □ PROPOSED AJ
 - BB PROPOSED IRISH WATER BOUNDARY BOX

ORDNANCE SURVEY IRELAND LICENCE No. EN 0057220
 © ORDNANCE SURVEY IRELAND / GOVERNMENT OF IRELAND

IRISH WATER STANDARD DETAILS AND CODE PRACTICE:
 ALL OF THE SITE DRAINAGE WORKS SHOULD BE CARRIED OUT IN ACCORDANCE WITH IRISH WATER'S (IW) "WASTEWATER INFRASTRUCTURE STANDARD DETAILS" AND "CODE OF PRACTICE FOR WASTEWATER INFRASTRUCTURE".

- PIPE MATERIALS:**
1. SERVICE CONNECTIONS FROM DWELLING TO BE 100mm Ø UNPLASTICISED PVC IN ACCORDANCE WITH SECTION 3.13 OF IW CODE PRACTICE.
 2. SITE SEWER TO BE THERMOPLASTIC STRUCTURED WALL PIPES IN ACCORDANCE WITH SECTION 3.13 OF THE IW CODE OF PRACTICE.

- TESTING:**
1. SITE SEWER AND MANHOLES TO BE TESTED IN ACCORDANCE WITH SECTION 4.10 OF IW CODE OF PRACTICE.
 2. CCTV AND MANHOLE CONDITION SURVEYS TO BE CARRIED OUT IN ACCORDANCE WITH SECTION 1.9 OF IW CODE OF PRACTICE IN ADVANCE OF THE DEFECTS LIABILITY PERIOD.

NOTE: ALL MANHOLE COVER LEVELS TO BE CHECKED IN SITU TO ENSURE THAT THEY ARE LEVEL WITH THE SURROUNDING FINISHED SURFACES.

3	PLANNING ISSUE	RK	BH	JR
		06/10/2020	06/10/2020	06/10/2020
2	PLANNING ISSUE	RK	BH	JR
		01/10/2020	01/10/2020	01/10/2020
REV.	DESCRIPTION	PRODUCER	VERIFIER	APPROVER
		DATE	DATE	DATE

PLANNING

DRA
 CONSULTING ENGINEERS

NSAI

DUBLIN | LIMERICK | WEXFORD
 T: 01-216-2956 | 061-310-701 | 053-915-2814
 E: info@drcconsulting.ie
 W: www.drcconsulting.ie


CLIENT:
 KILKENNY COUNTY COUNCIL

PROJECT:
 THOMASTOWN LIBRARY & COMMUNITY HALL,
 MARSH'S STREET,
 THOMASTOWN,
 KILKENNY

TITLE:
 PROPOSED SITE PLAN & WATER SERVICES

DATE:	11/09/2020	SCALES:	1:200 @ A1
DESIGNER:	BH	DRG. No.	
PRODUCER:	RK		
VERIFIER:	BH		
APPROVER:	JR		

			REV.
		K199-150	3

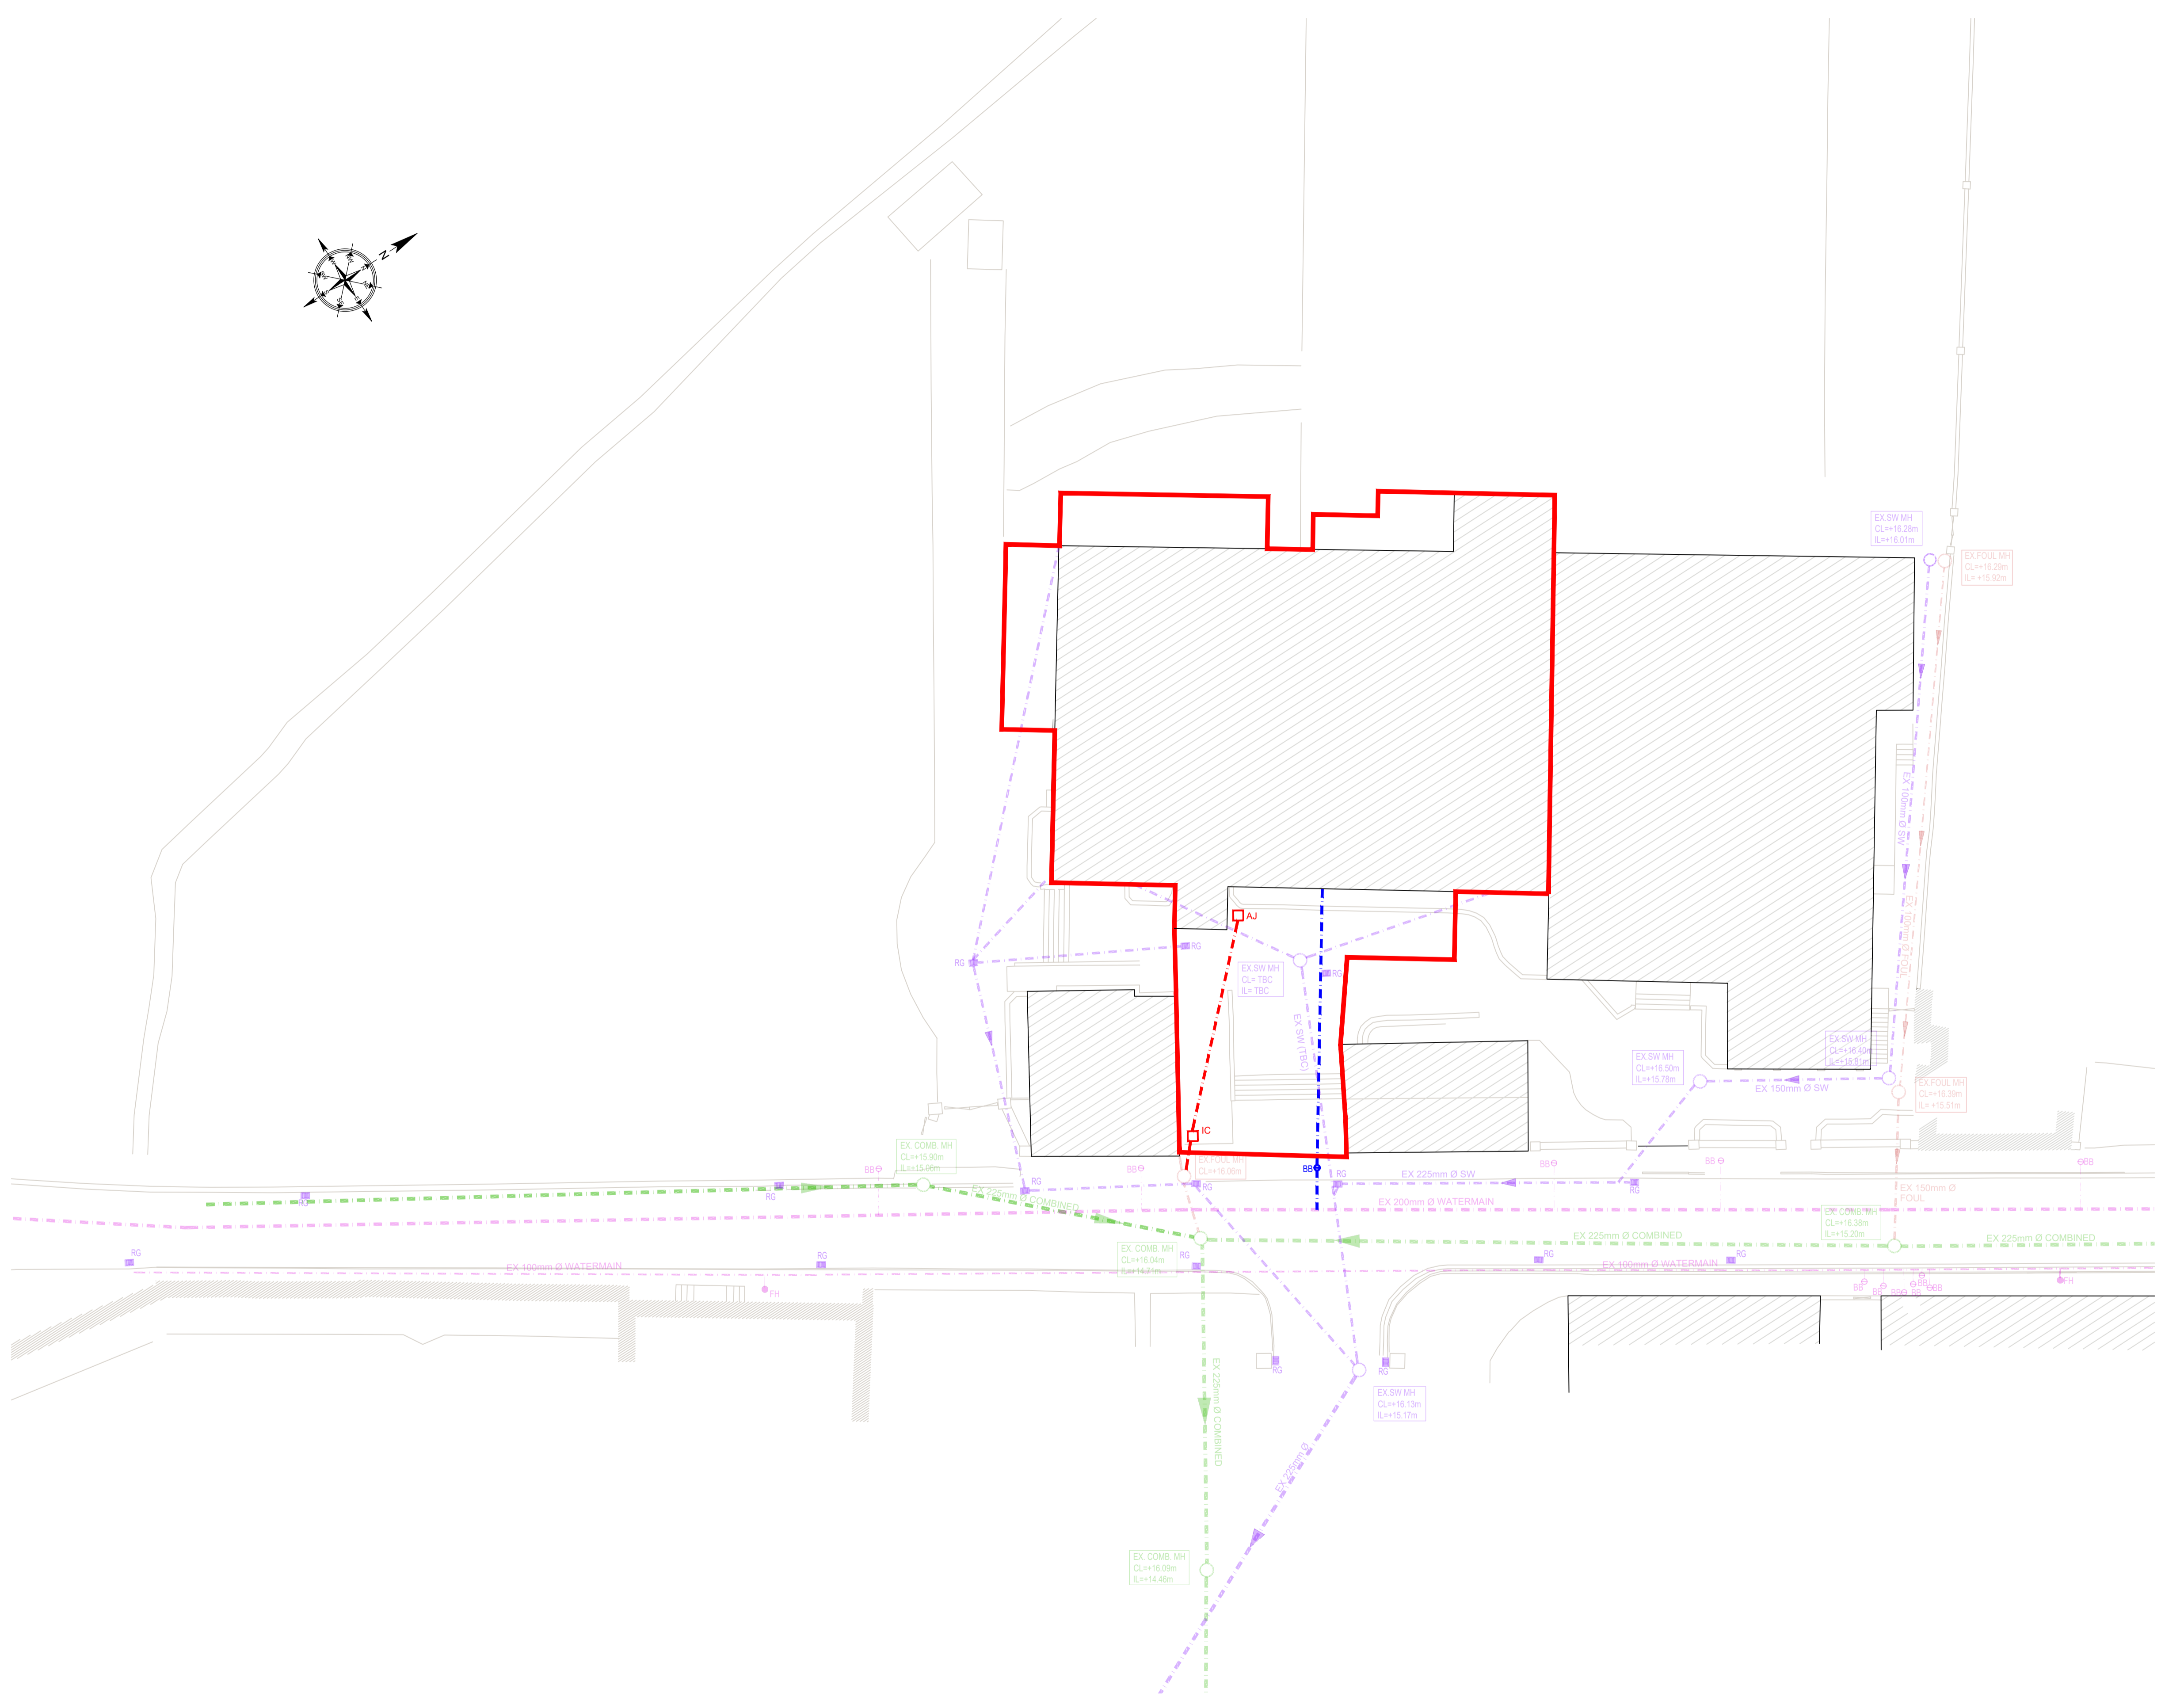

PROPOSED SITE PLAN & WATER SERVICES
 SCALE 1:200