

NOTES:

1. ORDNANCE SURVEY IRELAND LICENCE NUMBER EN0064809
2. FIGURED DIMENSIONS ONLY TO BE TAKEN FROM THIS DRAWING.
3. ALL LEVELS ARE IN METRES AND RELATE TO MALIN HEAD ORDNANCE DATUM.


LEGEND:

- SITE BOUNDARY
- EXISTING RIVER
- EXISTING STREAM
- CABLE PERCUSSION BOREHOLE WITH ROTARY CORE FOLLOW ON
- TRIAL PIT
- SLIT TRENCH (UTILITY SEARCH AND/OR FOUNDATION INSPECTION)
- INSPECTION PIT (WALL/FOUNDATION INSPECTION)

NOTE: LAND BASED SI WITHIN GRAIGUENAMANAGH TOWN ARE SHOWN ON DRAWING W3451-1104 (RIVER BASED SI ONLY SHOWN HERE)

\*NOTE: INSPECTION PITS WITHIN RIVER TO BE COMPLETED BY MEANS OF HAND DUG PITS ONLY UNLESS WRITTEN PERMISSION IS GIVEN BY BYRNELOOBY. PERMISSION TO UTILISE MECHANICAL PLANT WILL ONLY BE GIVEN WHERE THE CONTRACTOR CONFIRMS AND PROVIDES EVIDENCE OF LIAISON AND CO-ORDINATION WITH IFI AND NPWS AT LEAST 14 DAYS IN ADVANCE OF THE PROPOSED WORKS.

NOTE: LAND BASED SI WITHIN GRAIGUENAMANAGH TOWN ARE SHOWN ON DRAWING W3451-1104 (RIVER BASED SI ONLY SHOWN HERE)

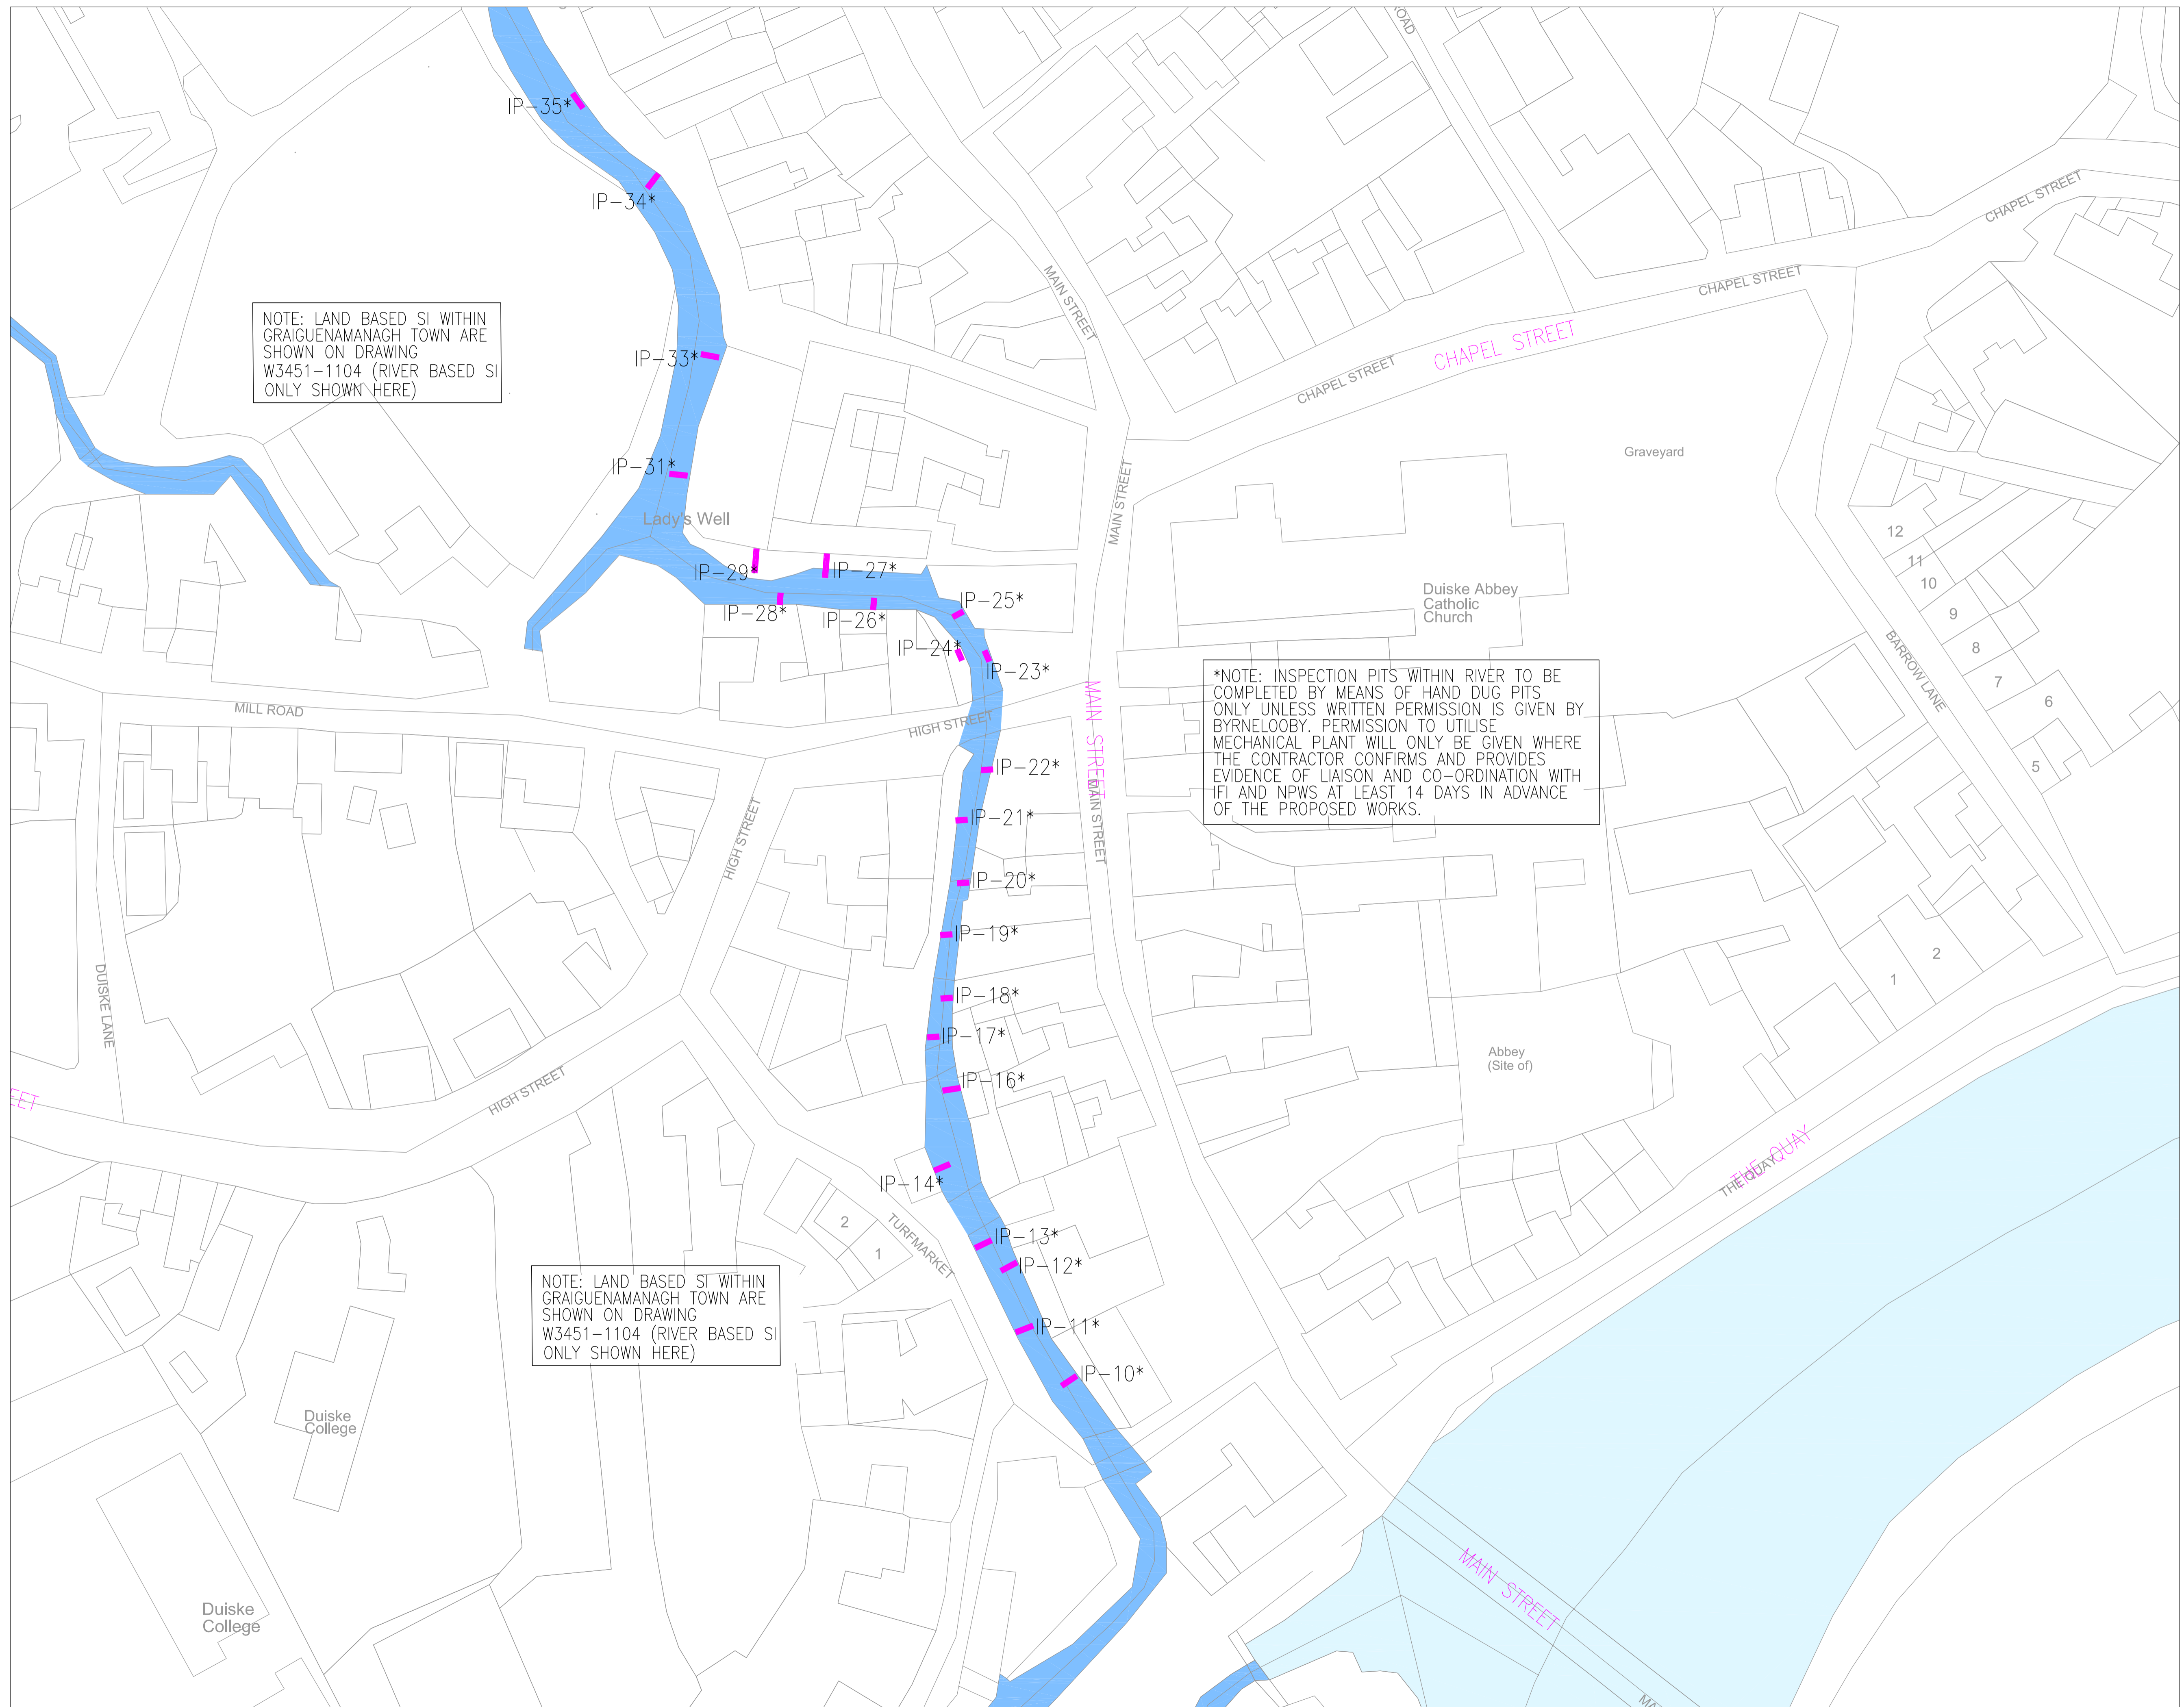

00	06.07.21	ISSUED FOR SI PLANNING	LT	SH	SH
Rev	Date	Description	By	Chk	App

**BYRNELOOBY**  
WWW.BYRNELOOBY.COM  
IRELAND | UK | UAE | BAHRAIN | KSA

CLIENT  
KILKENNY COUNTY COUNCIL

PROJECT  
GRAIGUENAMANAGH TINNAHINACH FRS

DRAWING TITLE  
SITE INVESTIGATION WORKS  
LAYOUT PLAN SHEET 5  
(RIVER BASED SI WORKS)

STATUS  
FOR PLANNING

Date: 05.07.21	Scale: 1:500	Drawn: LT	Chk: SH	App: SH
Project No: W3451	Org. No: W3451-1106			Rev: 00