


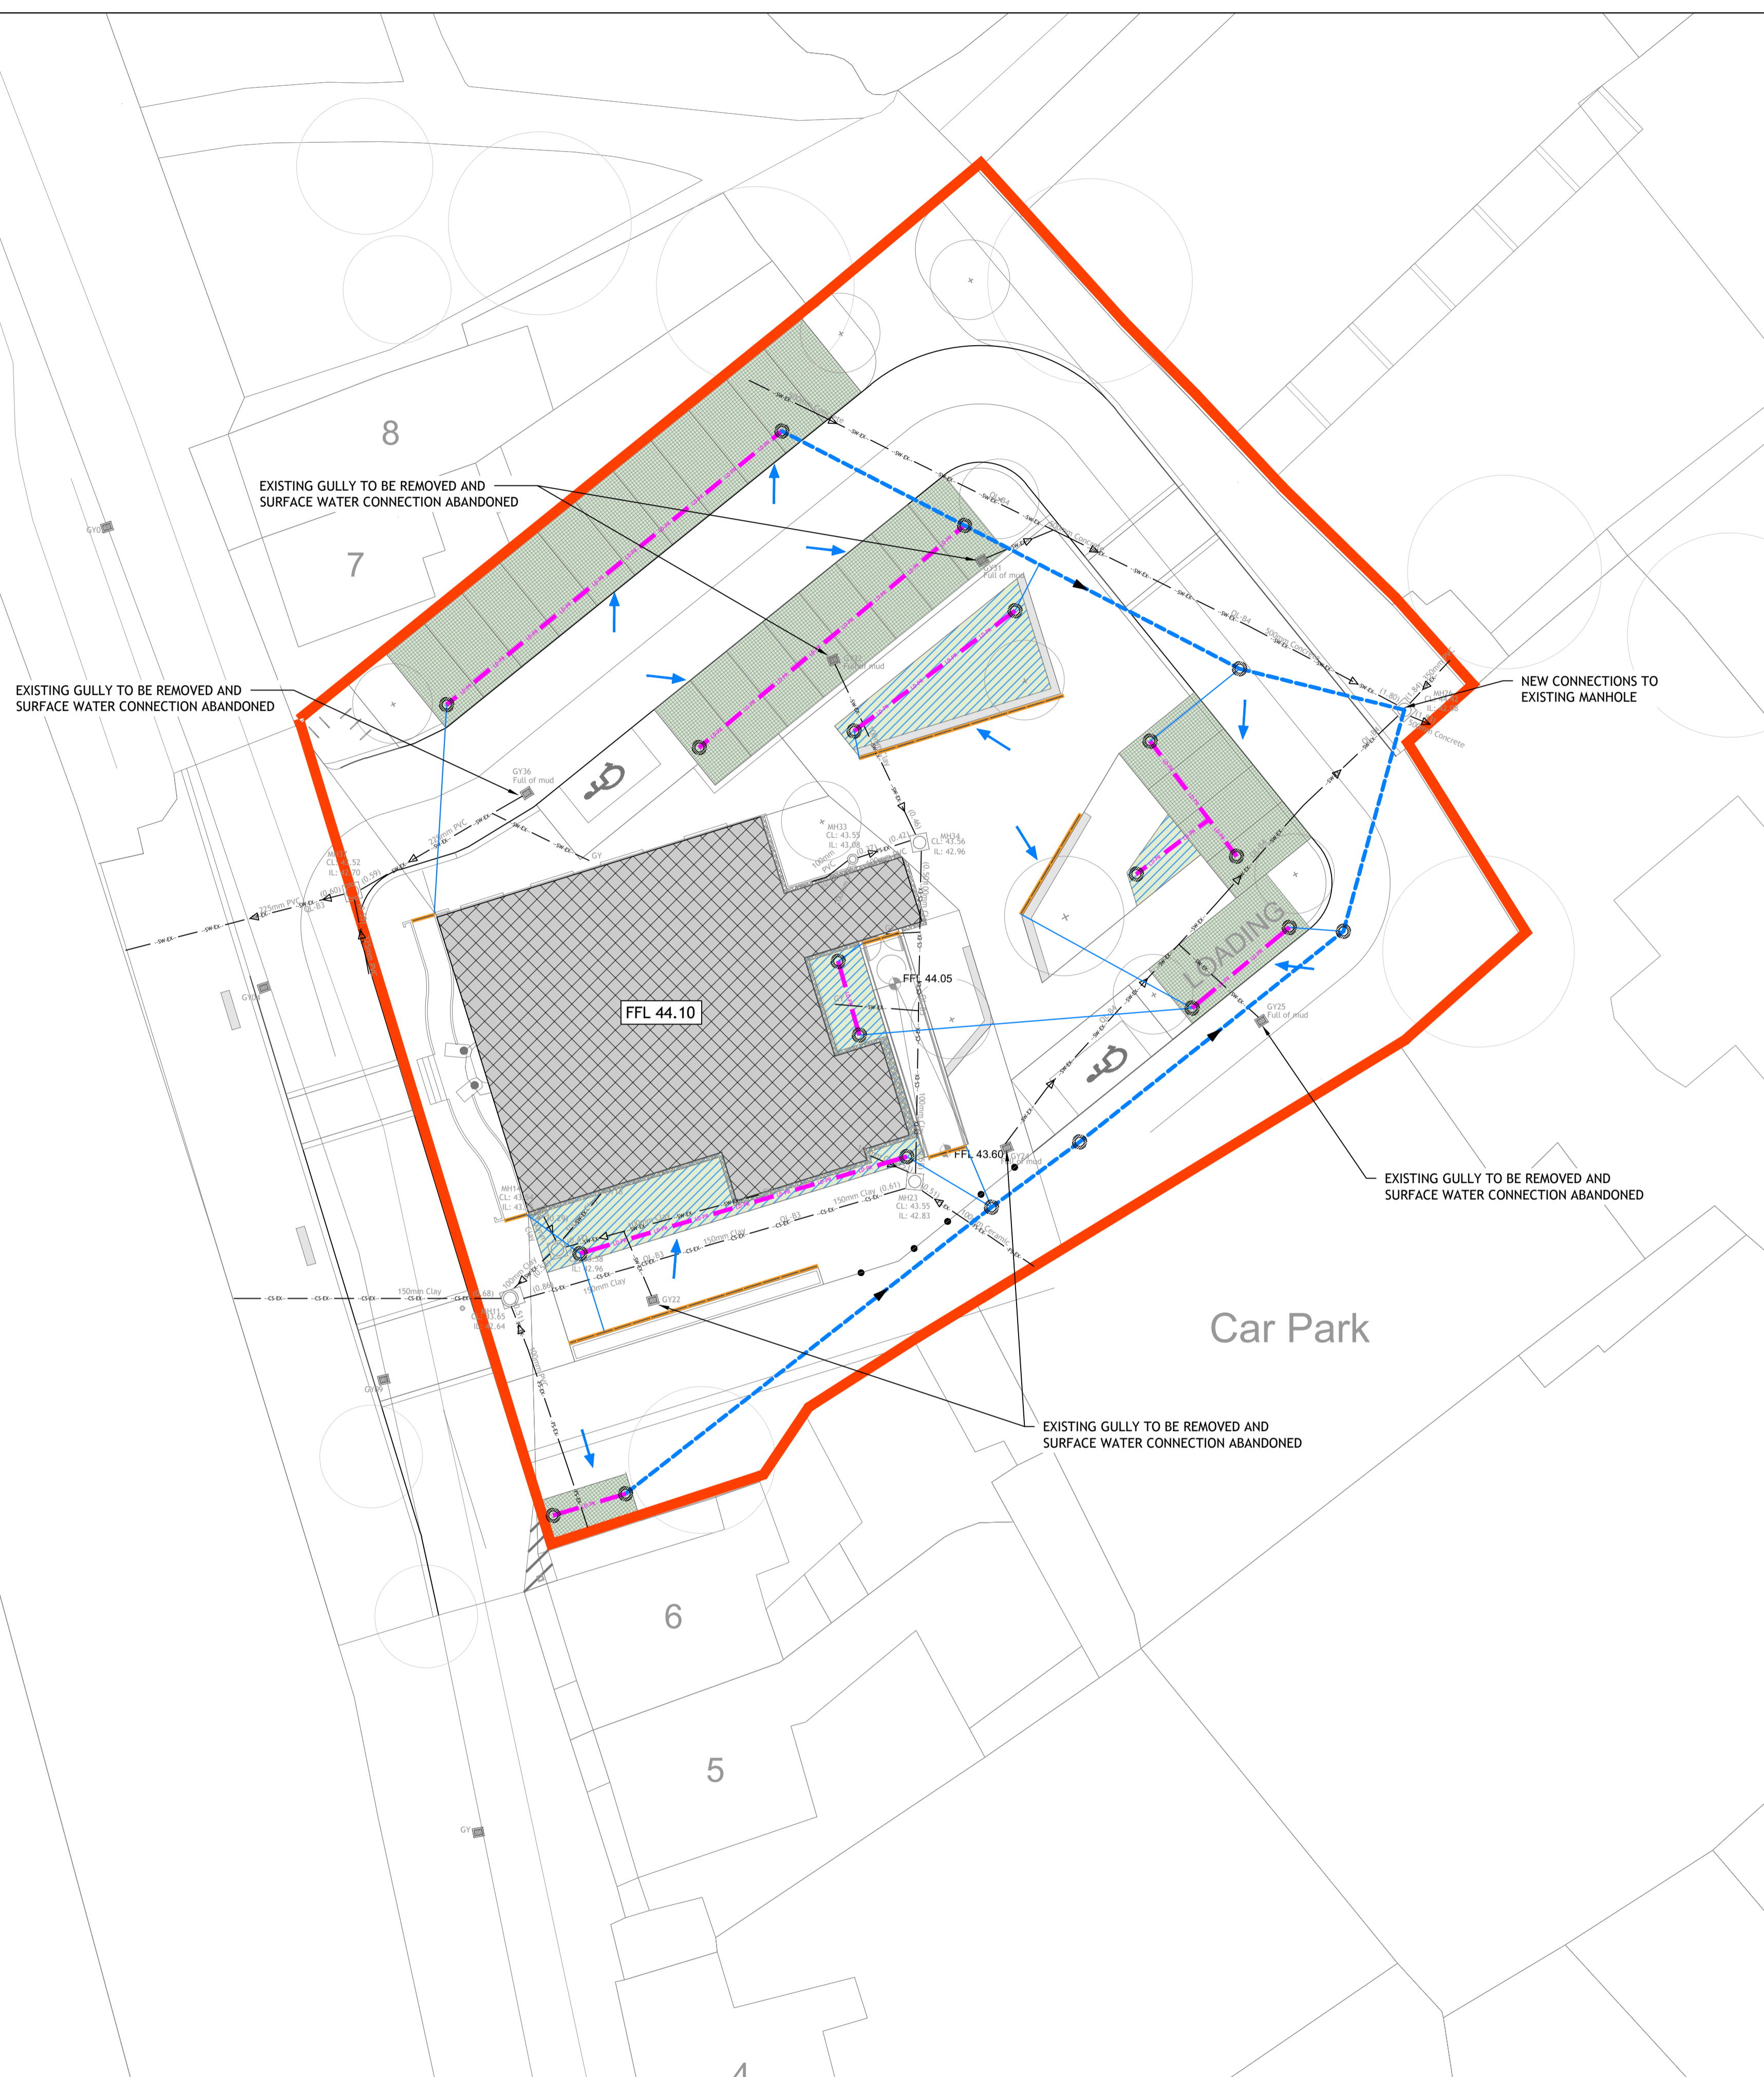


### LEGEND

- PROPOSED FILTER DRAIN
- PROPOSED SURFACE WATER SEWER (DETAILS TO BE CONFIRMED AT DETAILED DESIGN STAGE)
- PROPOSED SURFACE WATER CONNECTION PIPE
- PROPOSED SURFACE WATER INSPECTION CHAMBER (DETAILS TO BE CONFIRMED AT DETAILED DESIGN STAGE)
- PROPOSED CHANNEL DRAIN
- OVERLAND FLOW DIRECTION
- PROPOSED RAIN GARDEN (SuDS)
- PROPOSED GRASSCRETE (SuDS)
- SITE BOUNDARY

River Nore  
An Fheoir



© PUNCH Consulting Engineers  
 This drawing and any design hereon is the copyright of the Consultants and must not be reproduced without their written consent.  
 All drawings remain the property of the Consultants.  
 Figured dimension only to be taken from this drawing.  
 Consultants to be informed immediately of any discrepancies before work proceeds.

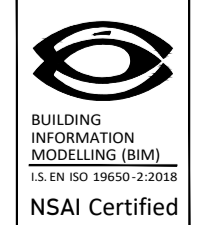

Rev	By	Date	Rev	By	Date	Client:
C01	DAP	2024-12-19				
ISSUED FOR PLANNING			Amendment			
Amendment			Amendment			



Project: KILKENNY URBAN DESIGN STRATEGY - CARNEGIE LIBRARY			
Title: PROPOSED SURFACE WATER DRAINAGE LAYOUT			
Drawn: D. PERSYNAKI	Date: NOVEMBER 2024	Technician Check: D. PERSYNAKI	Engineer Check: JP. MURRAY
Project No: 244175	Model Ref: 244175-PUNCH-XX-XX-M2-C-0125	Drawing Status: AO	Approved: AO
Scale @ A1: 1:200	Document No: 244175-PUNCH-XX-XX-DR-C-0125	Revision No: C01	